
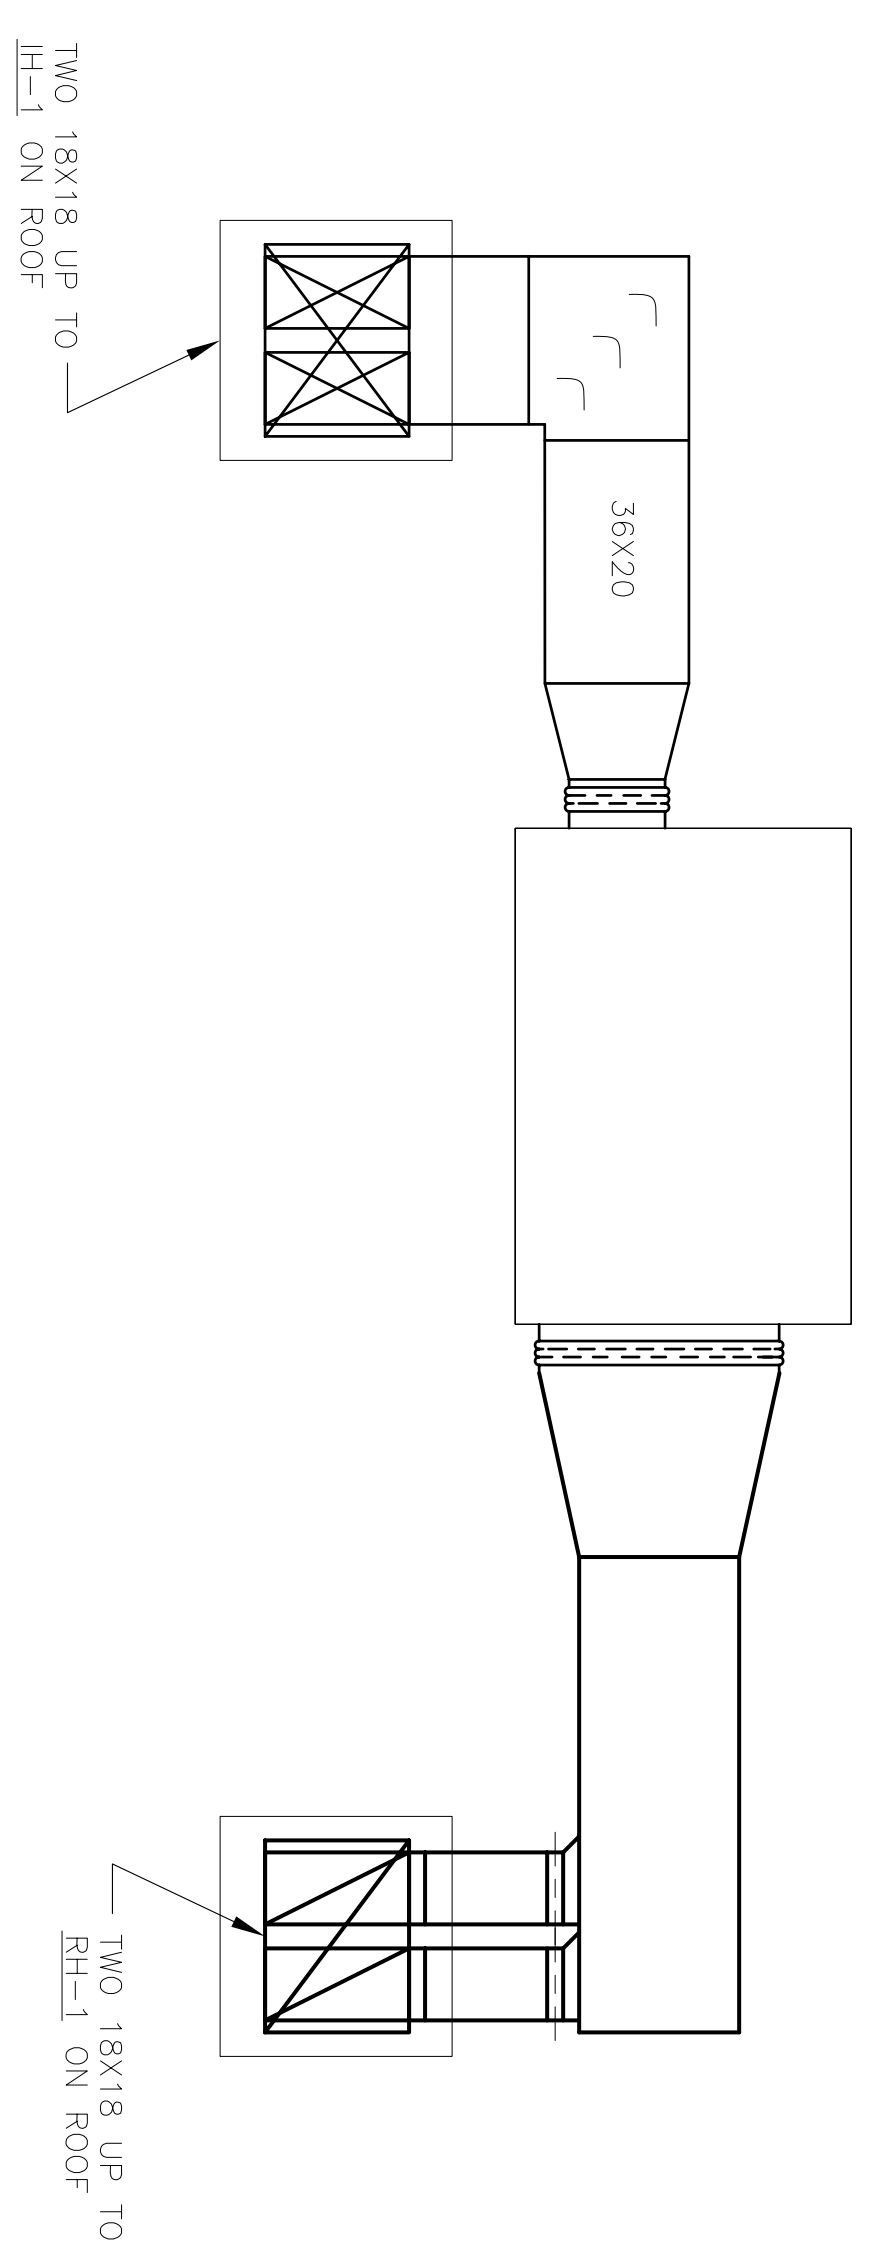
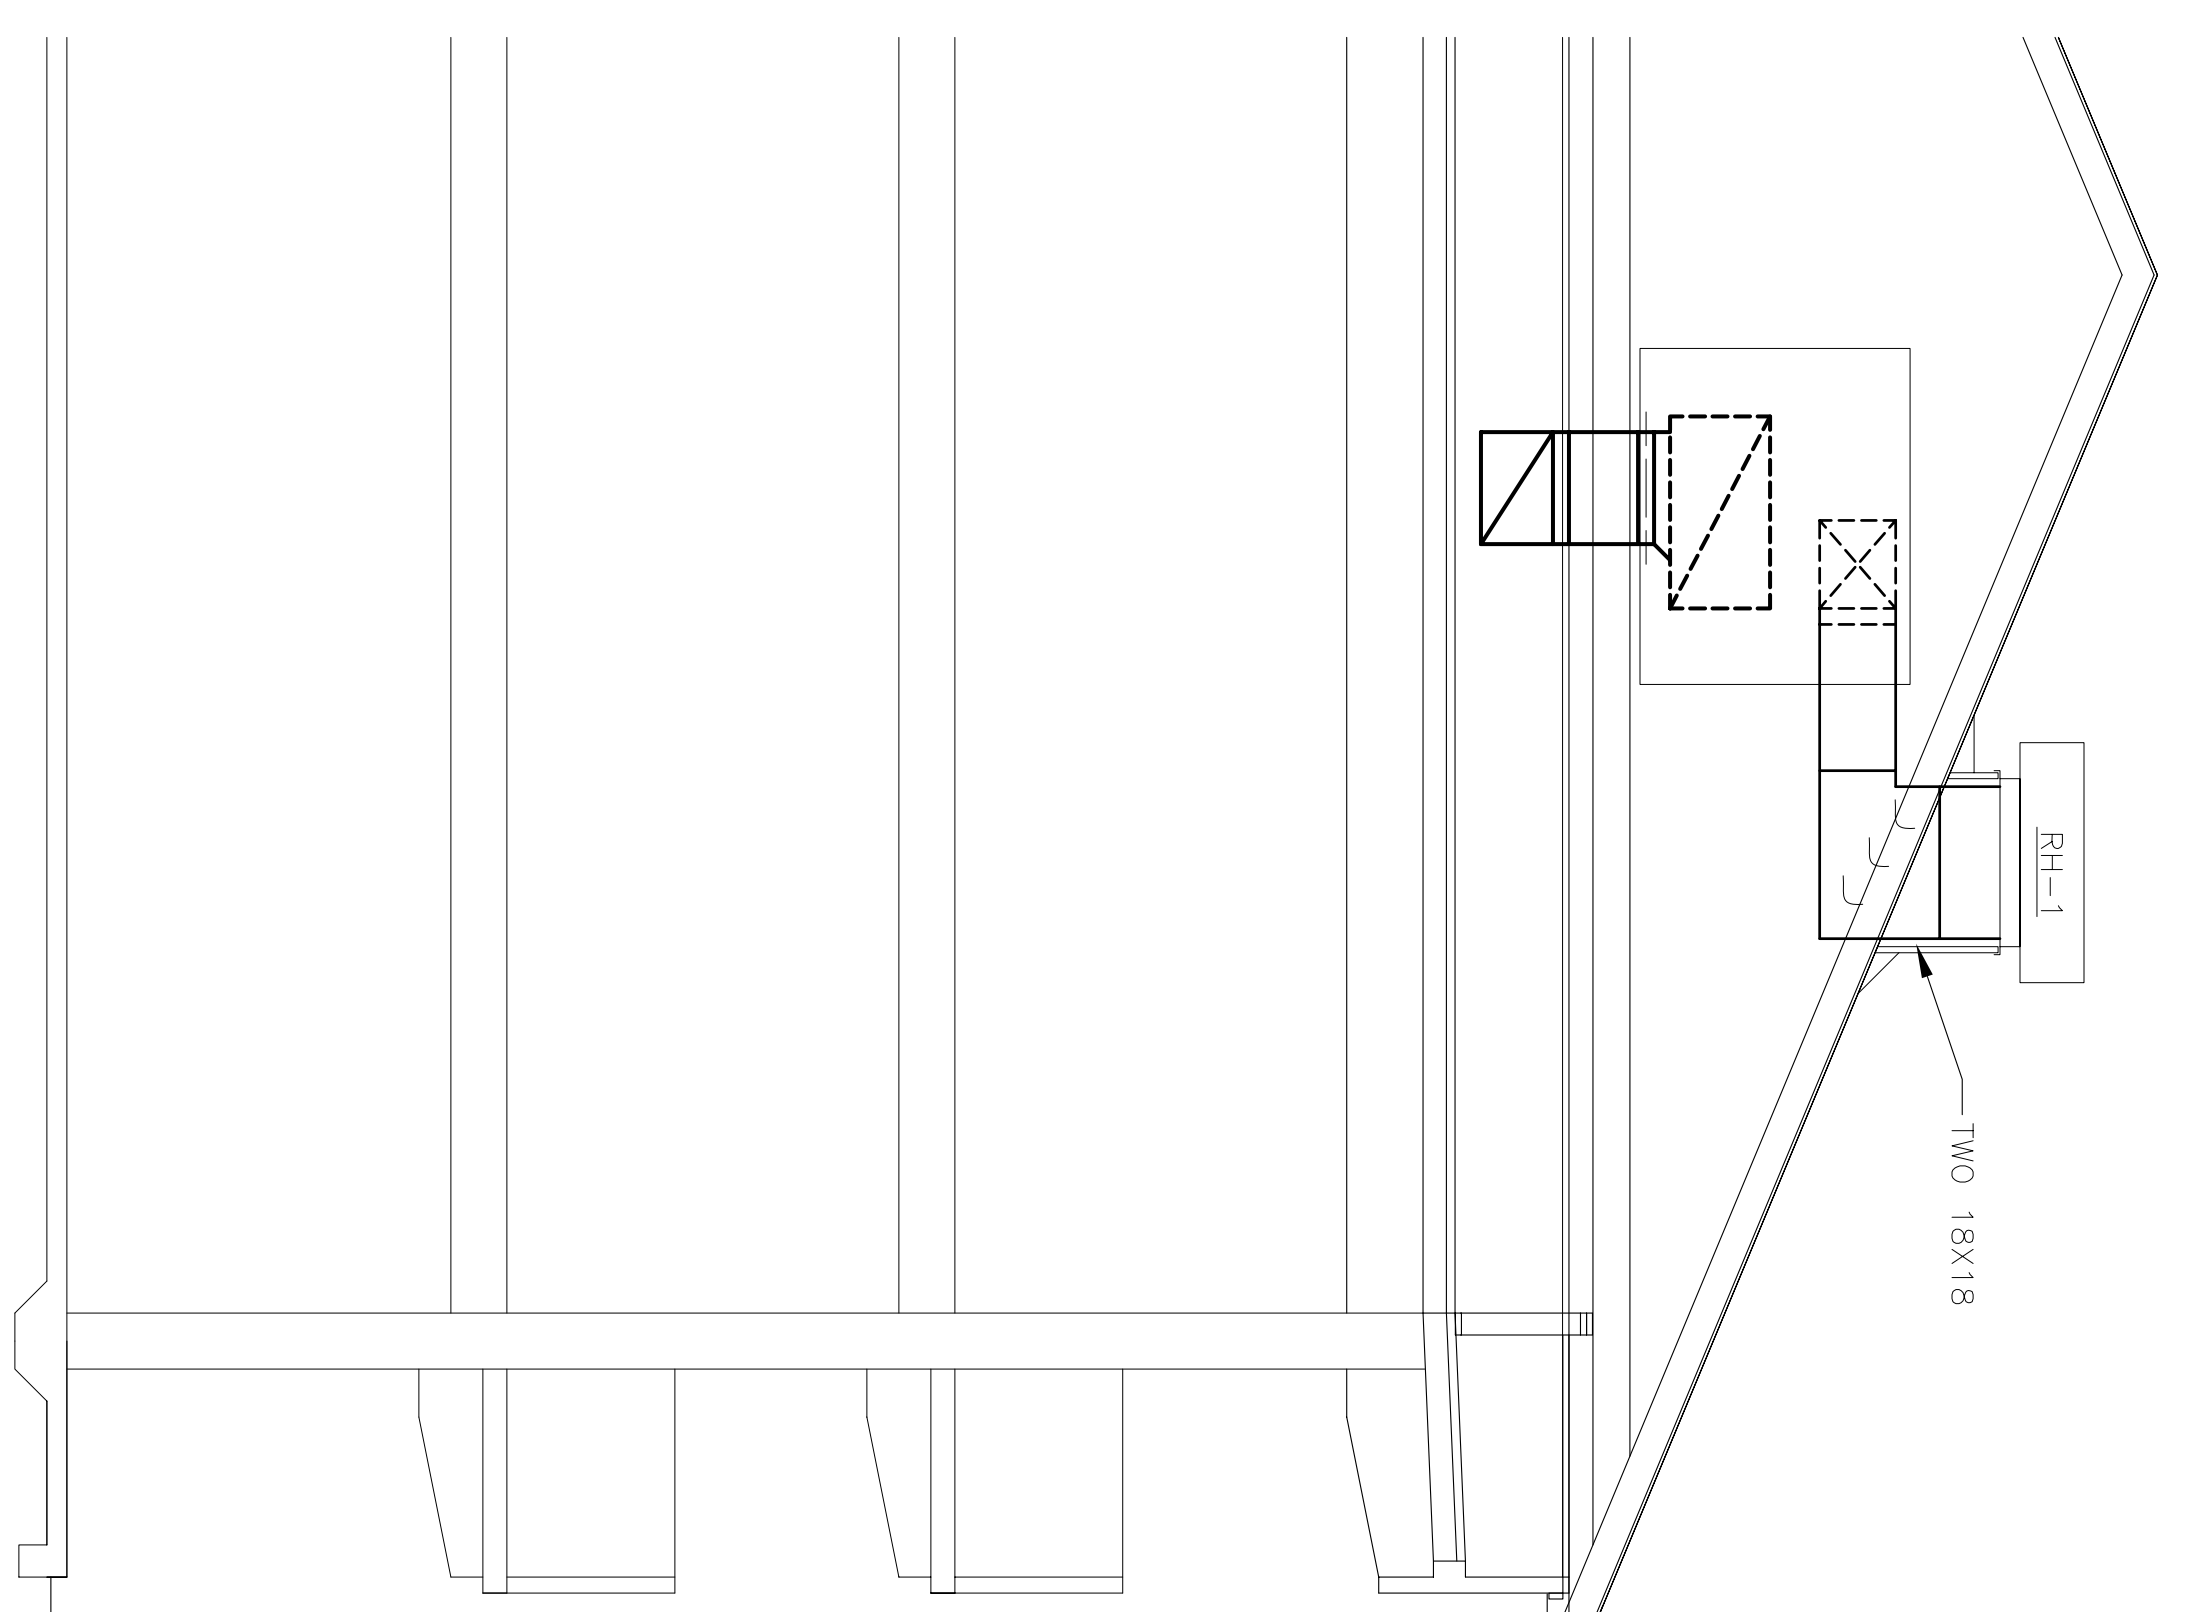
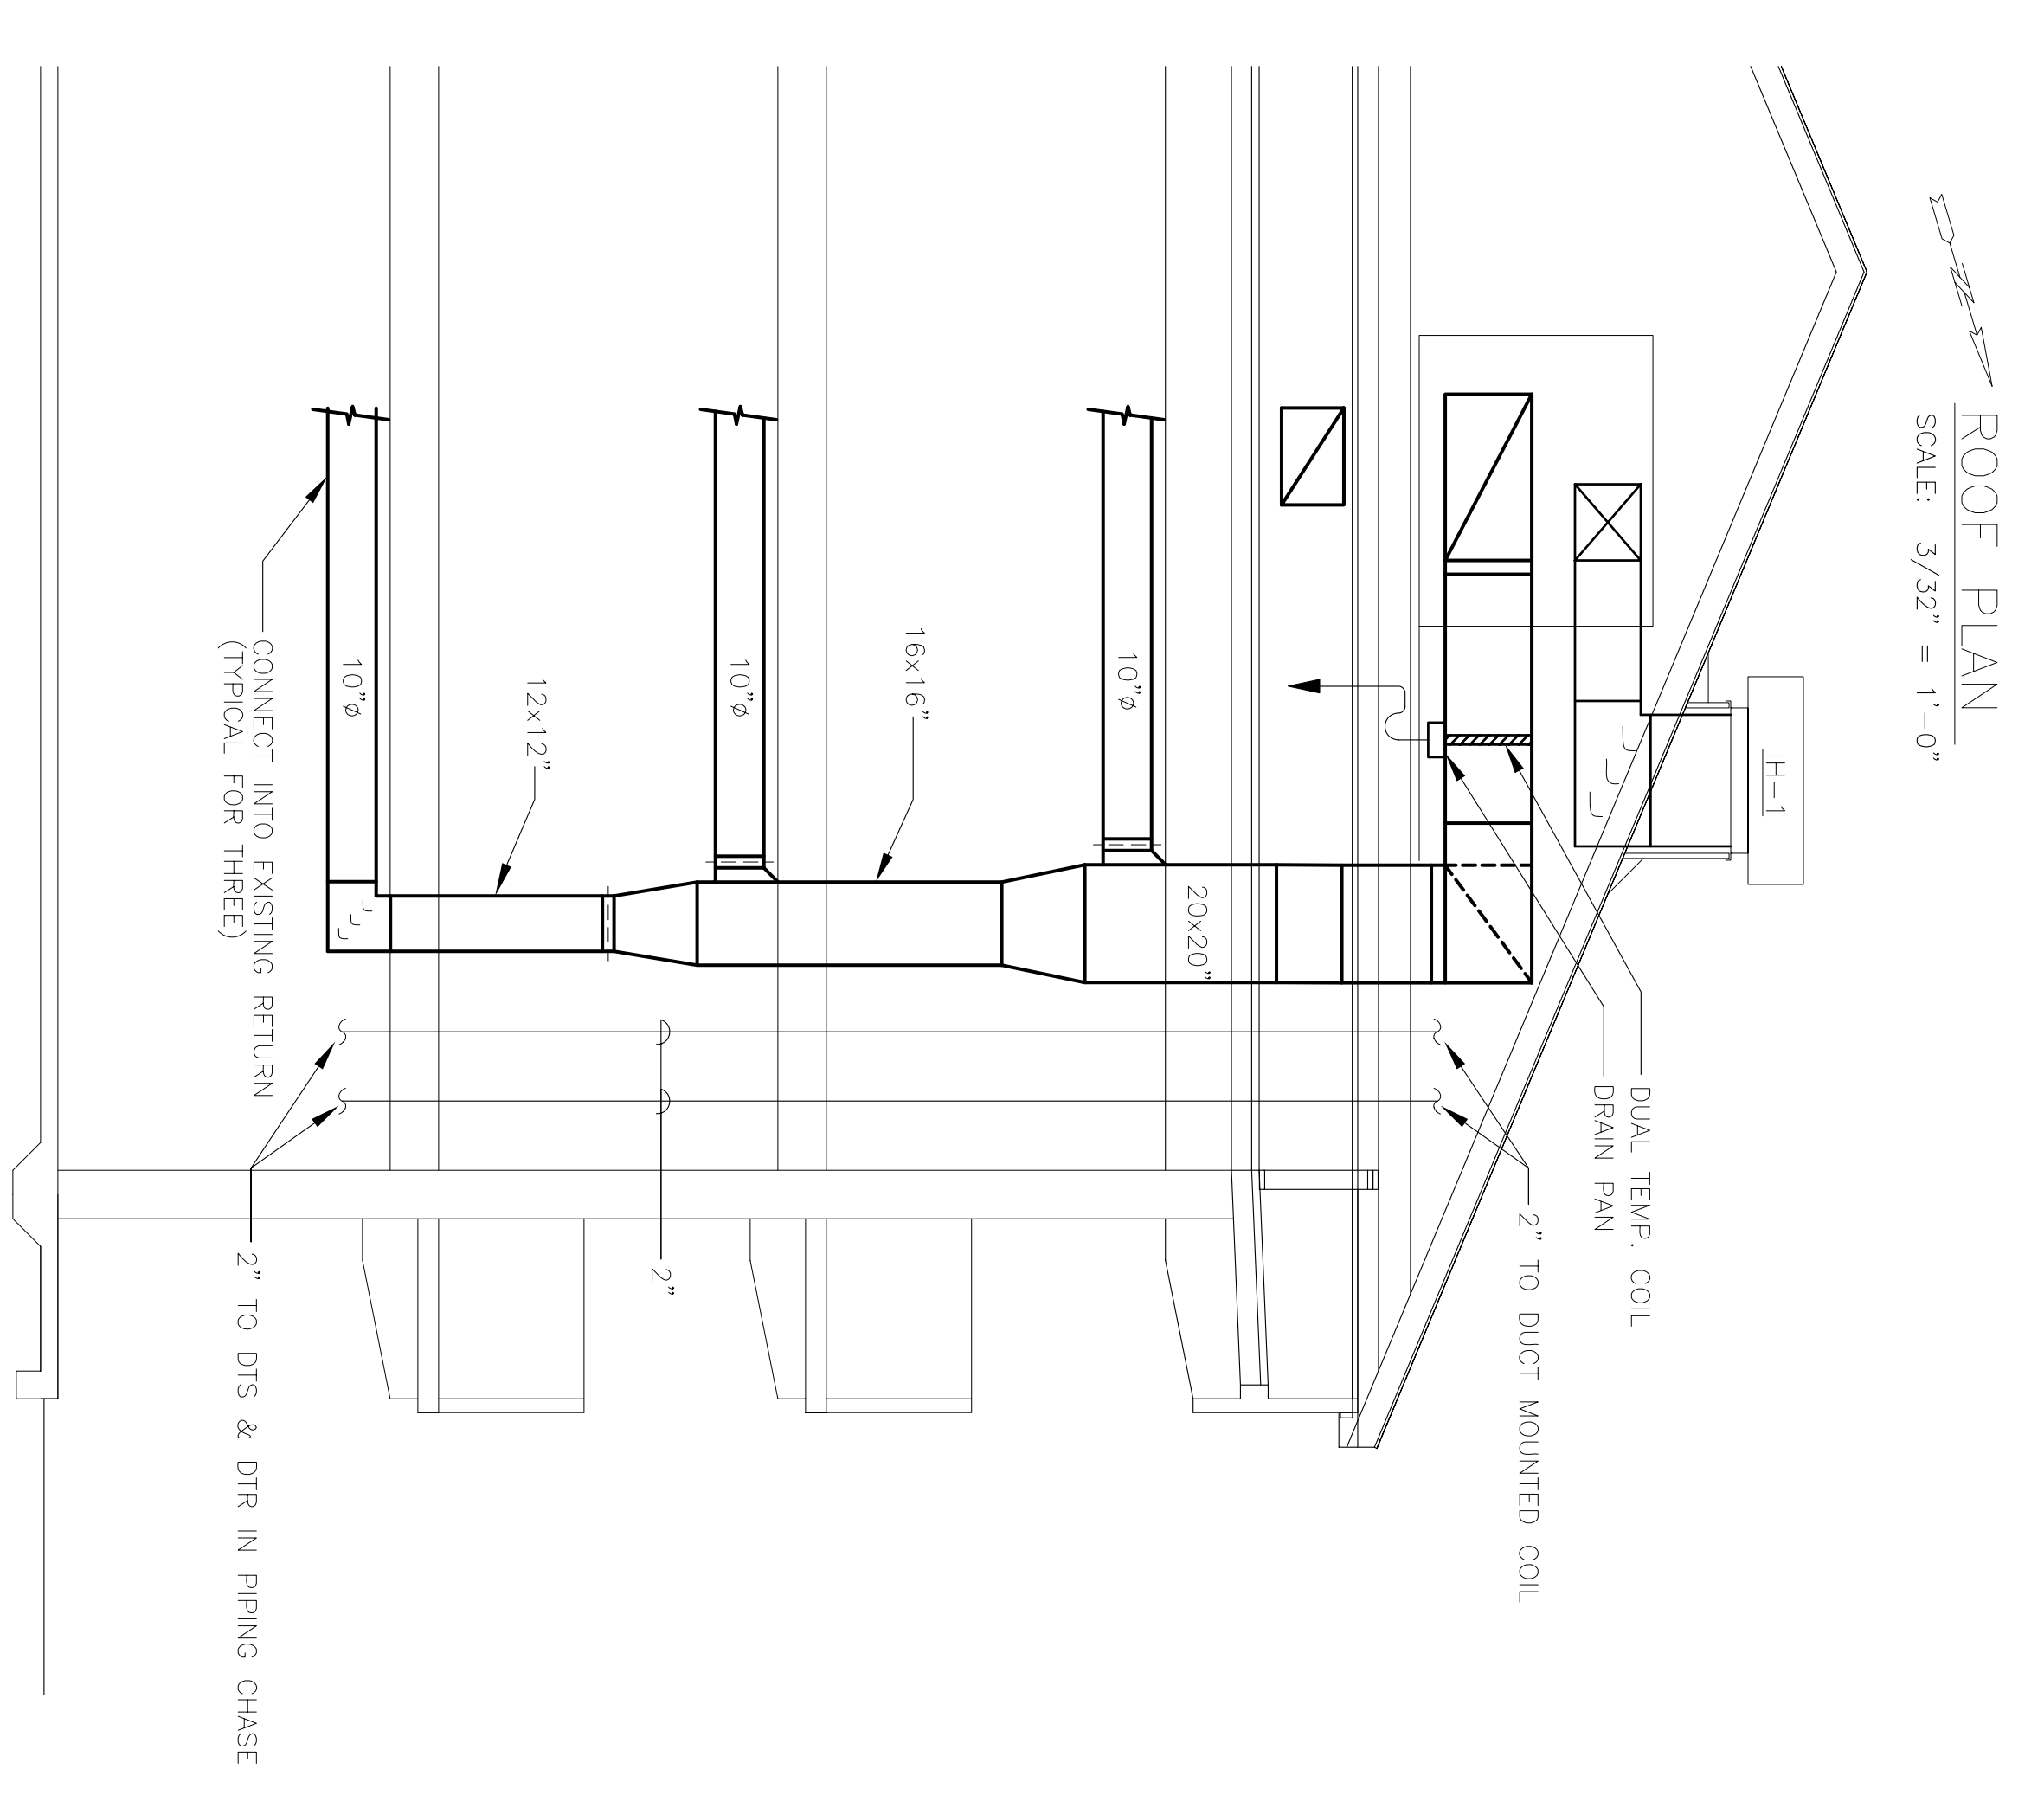
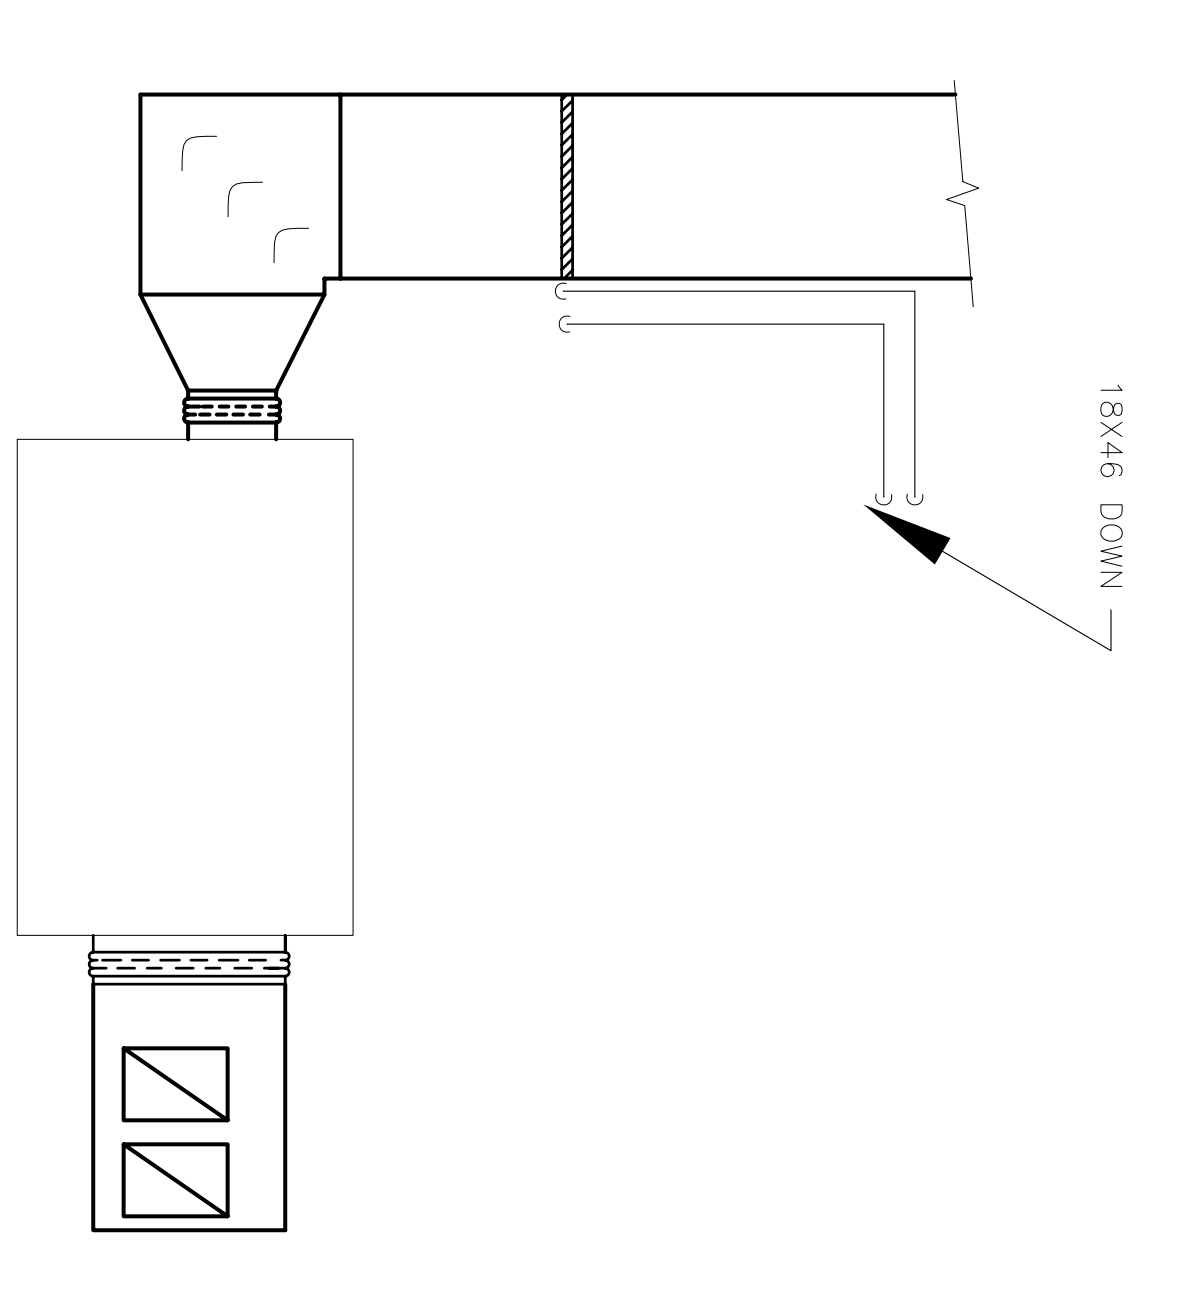


REVISIONS			
S/N	DESCRIPTION	DATE	APPROVED
1	REMOVED CLOSET EXHAUST, REVISED DUCTWORK SIZE	1.18.8	JAE LUOTT

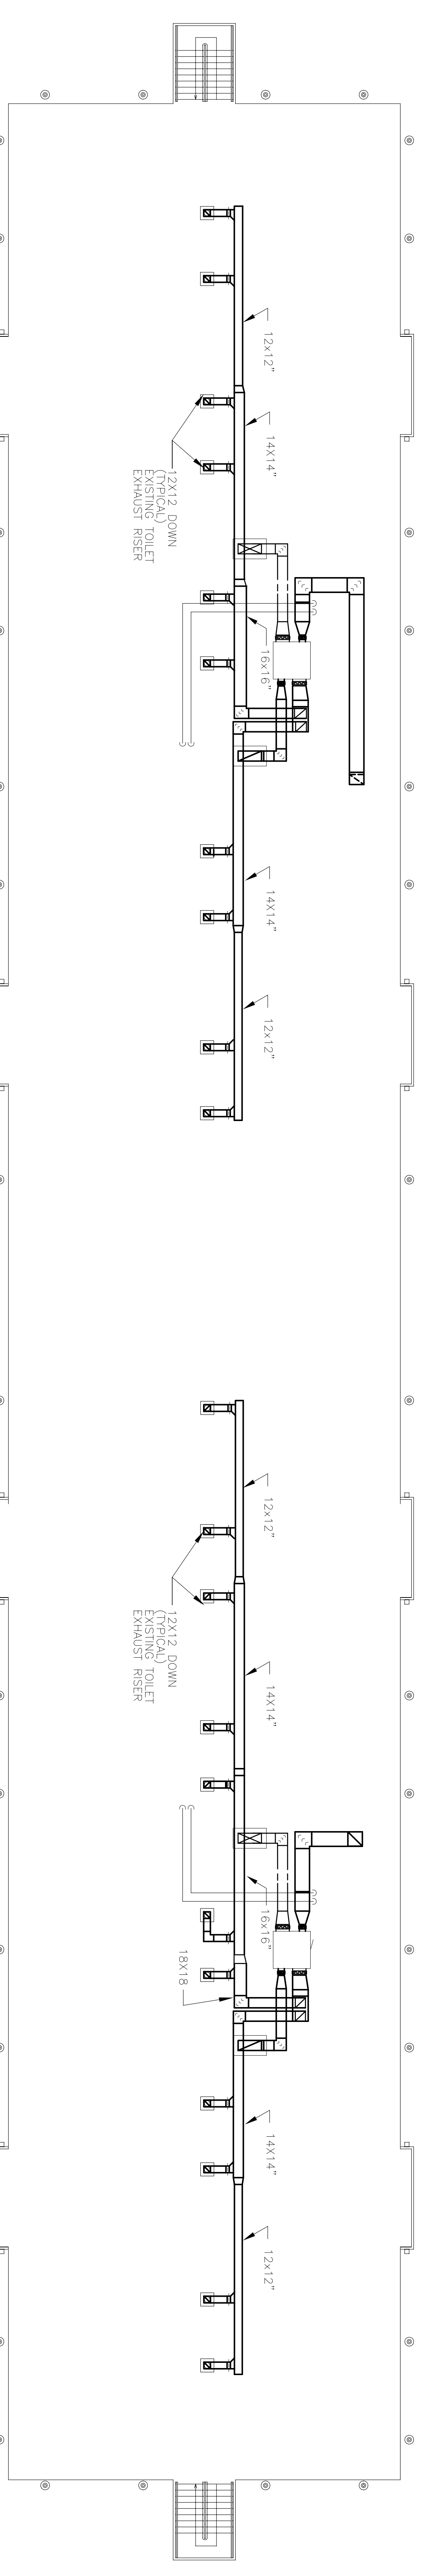

HEAT WHEEL PLAN - LOWER SECTION
SCALE: 1/4" = 1'-0"

HEAT WHEEL PLAN - LOWER SECTION
SCALE: 1/4" = 1'-0"

GRAPHIC SCALE:
SCALE: 3/32" = 1'-0"
0 4' 8' 12' 16' 20' 24' 28' 32'

GEOGRAPHIC AND CONSULTING ENGINEERS 510 S. BAYVIEW AVENUE CHARLOTTE, NC 28210 704-551-5727	ARCHITECT KANOV ARCHITECTURE, P.A. 1954 Summer Lake Road #218 Chapel Hill, NC 27514-5885 • Fax 319-373-8888 704-551-5727	DESIGNED BY: MSW DRAWN BY: MSW CHECK BY: SUBMITTED BY: DESIGN DIR: PWO OR OIC APPROVED: PWO OR OIC DATE: 5/1/06	MAJOR INTERIOR/EXTERIOR REPAIRS TO BUILDING AS-4035 FLOOR PLAN - NEW WORK SIZE CODE IDENT. NO. 12504175 NAA/FAC DRAWING NO. 80091 CONST. CONTR. NO. N40085-06-B-0049 SHEET 18 OF 27	M-3